


Peter J. Lesdow  
architect

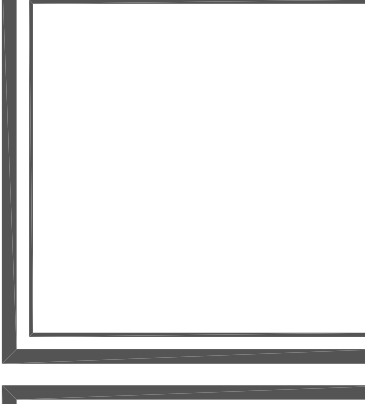

SITE LIGHTING PHOTOMETRIC  
144 & 176 John St


DATE	REVISIONS	DATE	REVISIONS
Apr. 07/20	FOR REDLINE		

RITZ-CARLTON  
DEVELOPMENT  
144, 176 & 200 John St, 855 Chenotte St  
Niagara-on-the-Lake

DATE: Nov. 18/22  
SCALE: NTS  
DRAWN BY:  
CHECK BY:

22 - 13

E100

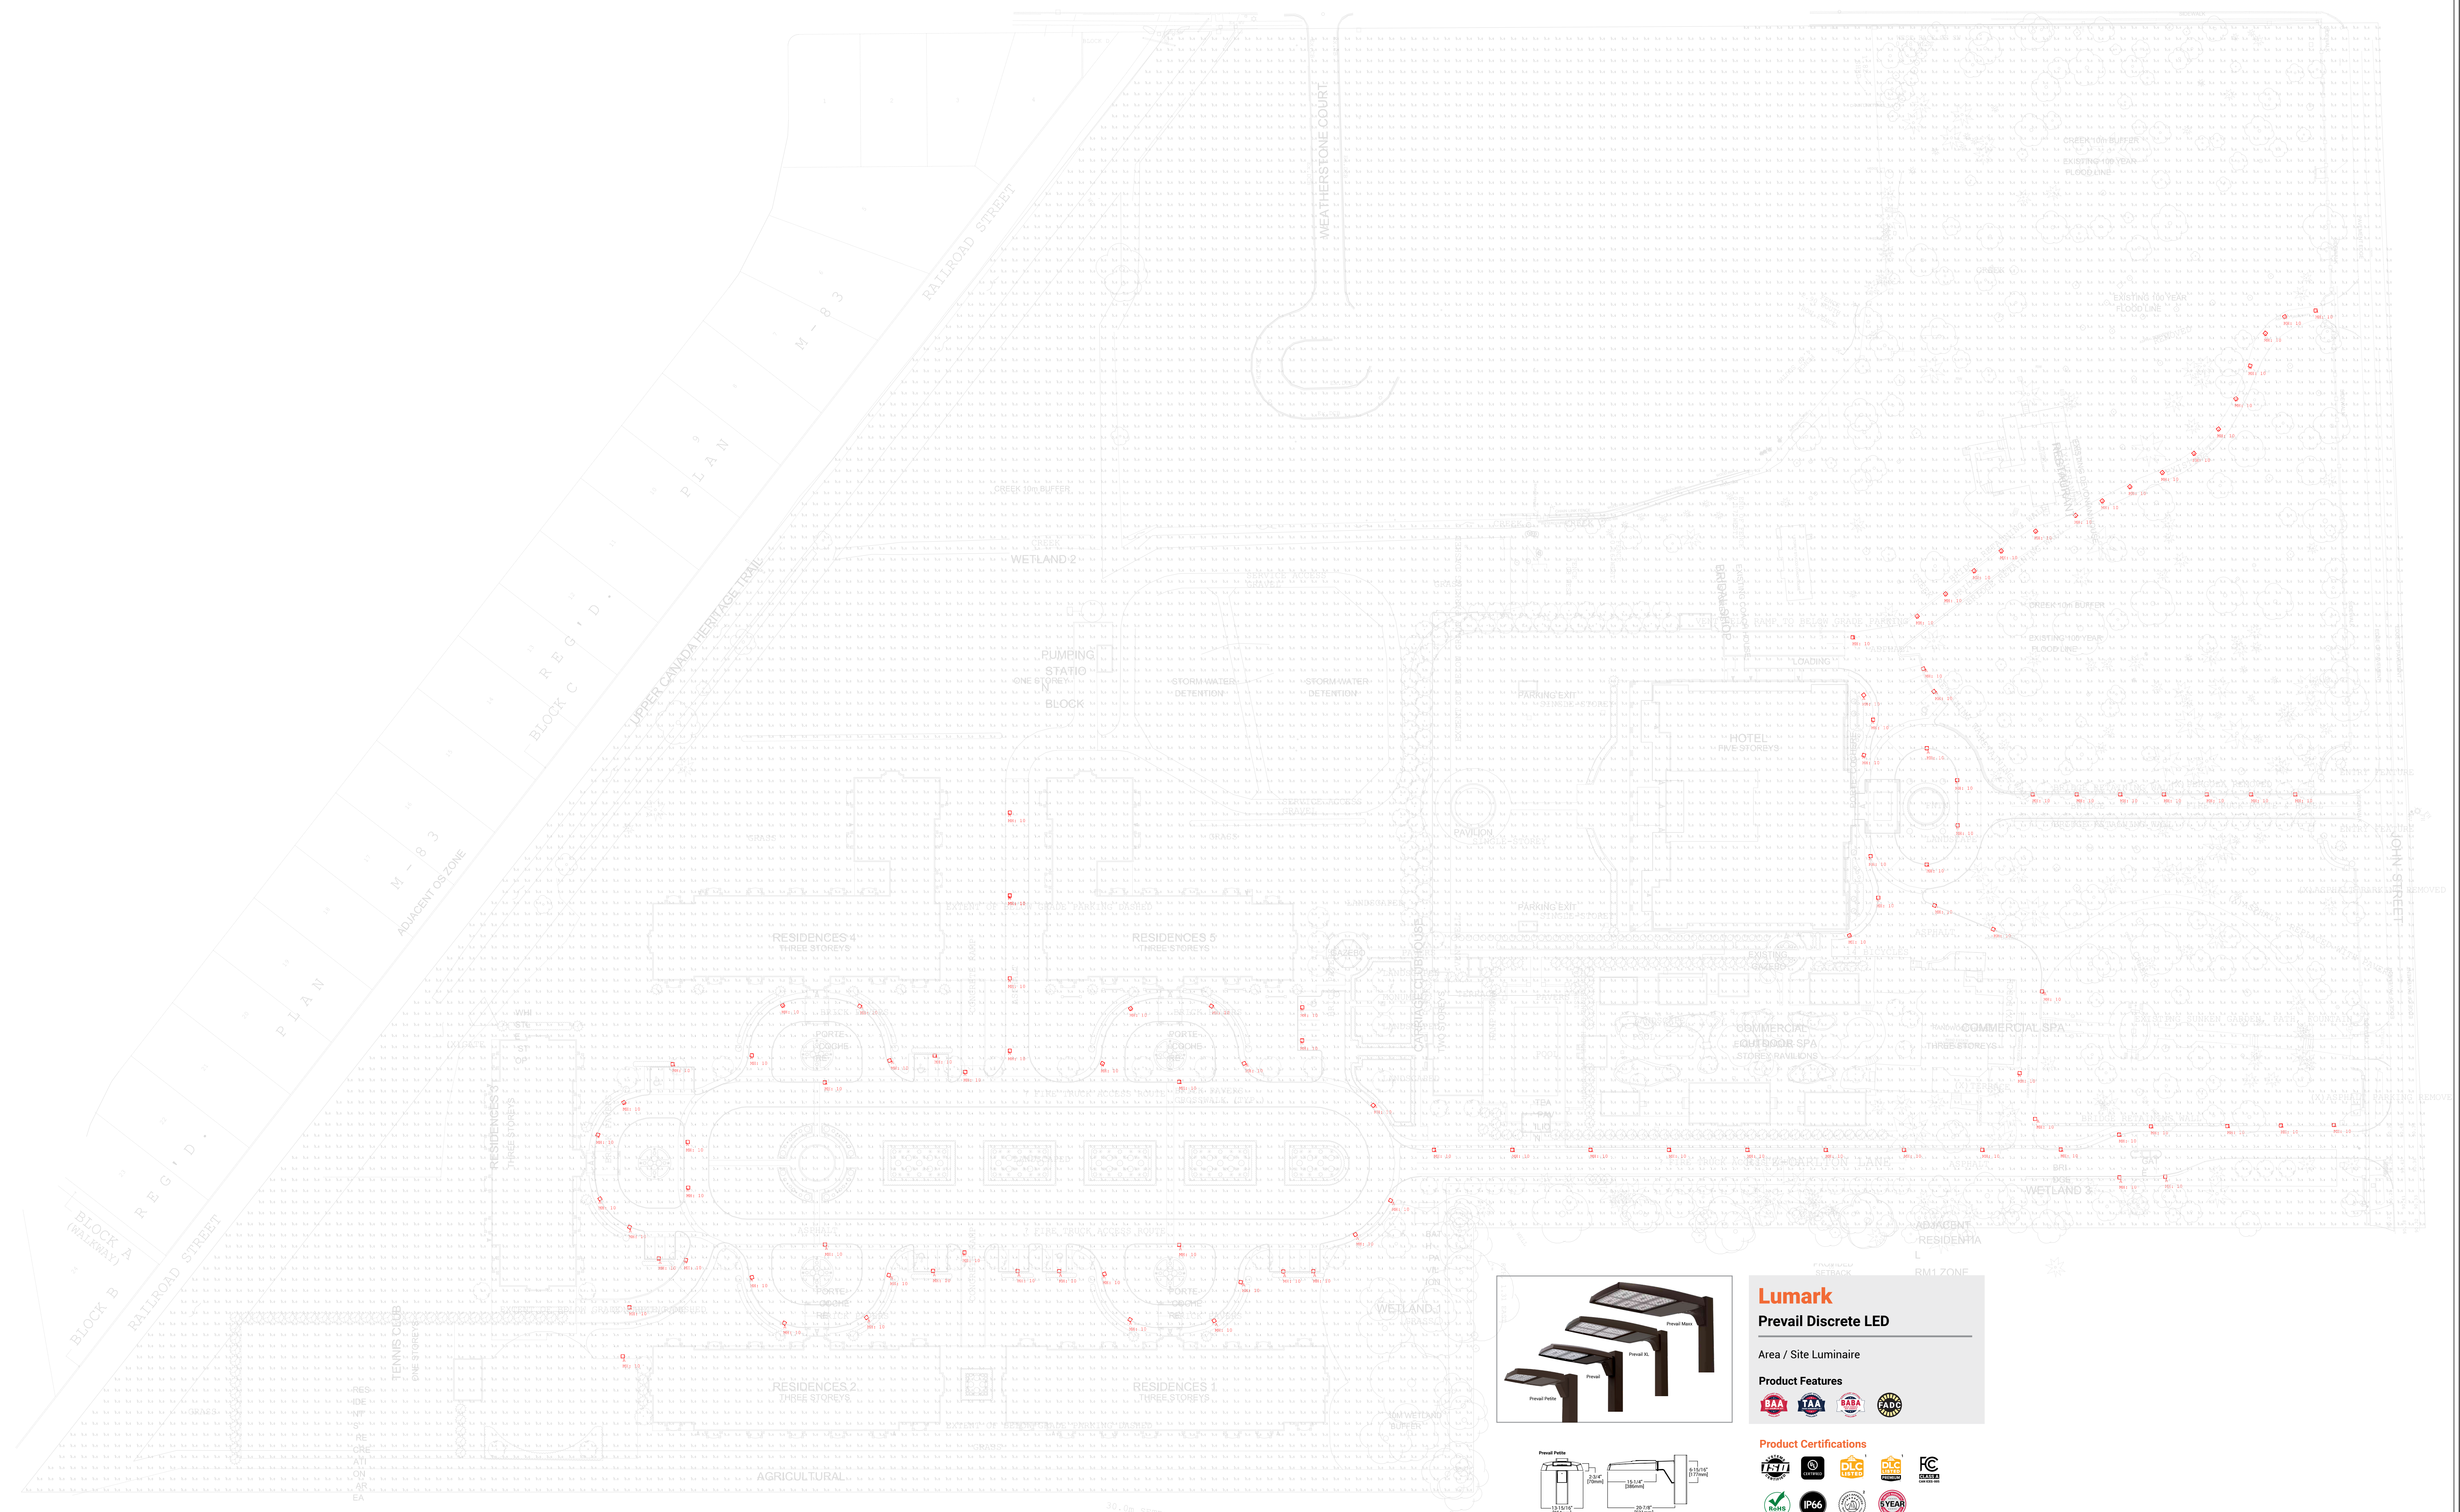


**Lumark**  
Prevail Discrete LED

Area / Site Luminaire

Product Features

- BAA
- TAA
- FABA
- FADC

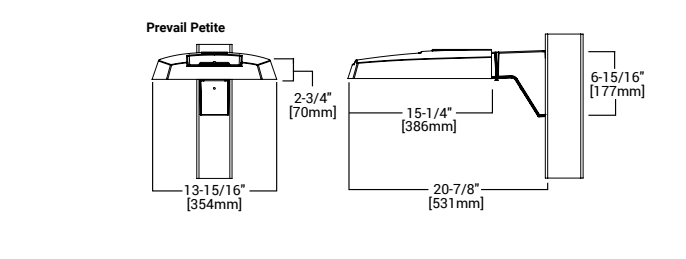

Product Certifications

- UL LISTED
- IP60
- DLC E9
- FC
- ETL

Luminaire Schedule	Symbol	Qty	Label	Arrangement	Description	Tag	LLF	Luminaire Lumens	Luminaire Watts	Total Watts
	106		PRV-PA1A-750-U-T4X	Single	PRV-PA1A-750-U-T4X	A	0.900	7484	54	5724